


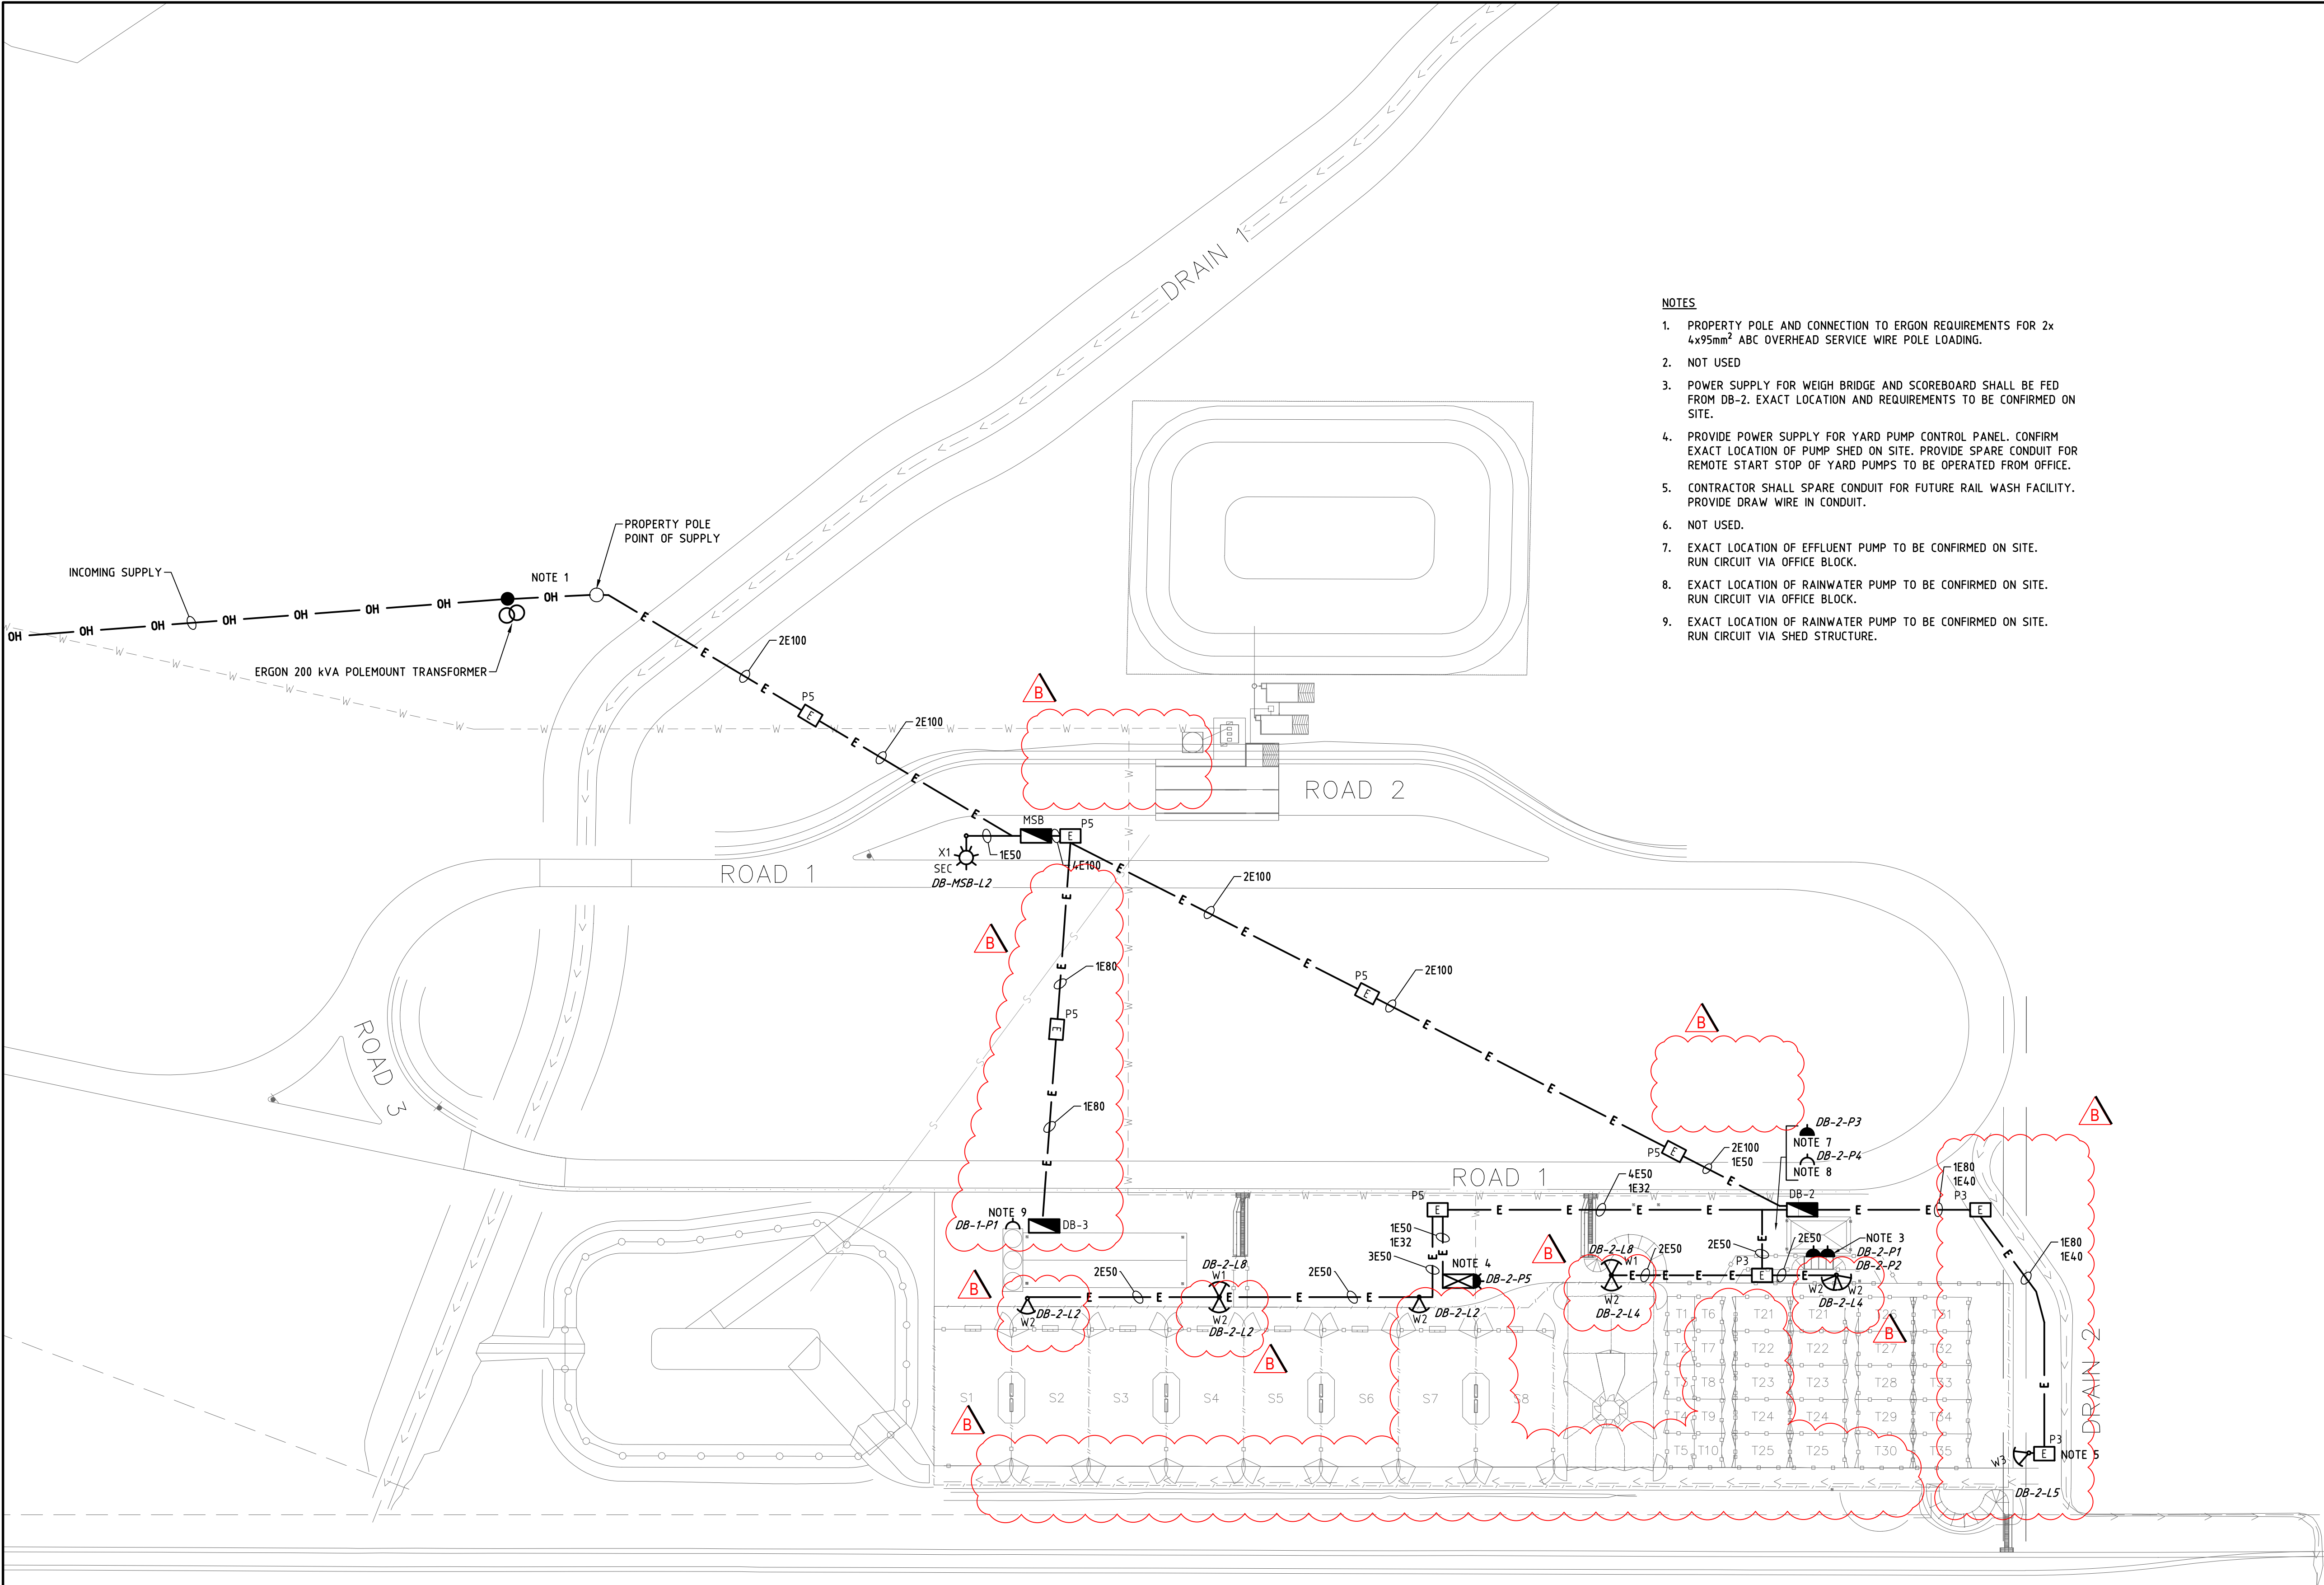


- NOTES**
1. PROPERTY POLE AND CONNECTION TO ERGON REQUIREMENTS FOR 2x 4x95mm<sup>2</sup> ABC OVERHEAD SERVICE WIRE POLE LOADING.
  2. NOT USED
  3. POWER SUPPLY FOR WEIGH BRIDGE AND SCOREBOARD SHALL BE FED FROM DB-2. EXACT LOCATION AND REQUIREMENTS TO BE CONFIRMED ON SITE.
  4. PROVIDE POWER SUPPLY FOR YARD PUMP CONTROL PANEL. CONFIRM EXACT LOCATION OF PUMP SHED ON SITE. PROVIDE SPARE CONDUIT FOR REMOTE START STOP OF YARD PUMPS TO BE OPERATED FROM OFFICE.
  5. CONTRACTOR SHALL SPARE CONDUIT FOR FUTURE RAIL WASH FACILITY. PROVIDE DRAW WIRE IN CONDUIT.
  6. NOT USED.
  7. EXACT LOCATION OF EFFLUENT PUMP TO BE CONFIRMED ON SITE. RUN CIRCUIT VIA OFFICE BLOCK.
  8. EXACT LOCATION OF RAINWATER PUMP TO BE CONFIRMED ON SITE. RUN CIRCUIT VIA OFFICE BLOCK.
  9. EXACT LOCATION OF RAINWATER PUMP TO BE CONFIRMED ON SITE. RUN CIRCUIT VIA SHED STRUCTURE.

© Copyright Ashburner Francis Pty. Ltd., 2020.  
These drawings and designs and the copyright thereof are the property of Ashburner Francis Pty. Ltd. and must not be used, retained or copied without the written permission of Ashburner Francis Pty. Ltd.

**ELECTRONIC TRANSFER**

 Where this drawing has been transferred by electronic media, no responsibility is accepted for the usability, completeness or accuracy of the electronic data.  
Check reference scale below to confirm accuracy of drawing reproduction



|       |          |                      |       |
|-------|----------|----------------------|-------|
|       |          |                      |       |
|       |          |                      |       |
|       |          |                      |       |
|       |          |                      |       |
|       |          |                      |       |
|       |          |                      |       |
|       |          |                      |       |
|       |          |                      |       |
| B     | 17/08/20 | REVISED TENDER ISSUE | JK    |
| A     | 16/07/20 | TENDER ISSUE         | JK    |
| issue | date     | description          | init. |

client

**MURWEH  
SHIRE  
COUNCIL**

architect



**Ashburner  
Francis** consulting  
engineers

ASHBURNER FRANCIS PTY LTD (A.B.N. 46 009 975 197)

■ **TOOWOOMBA**

Unit 5, 323 Ruthven Street,  
Toowoomba Qld 4350  
t: (07) 4512 6070  
e: toowoomba@ashburnerfrancis.com.au

□ **BRISBANE**  
□ **TOWNSVILLE**  
□ **DARWIN**

**ELECTRICAL SERVICES**

project

**MORVEN LIVESTOCK  
TRANSPORT  
INTERCHANGE**


location

title

**SITE POWER & LIGHTING LAYOUT**

date: APR '20

scale: 1:750 @A1

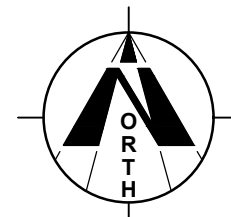

designed: JK

drawn: JK

checked: GK

CAD file name:

19-0771

E050

B

job no.

sheet

issue

**TENDER ISSUE**